





REFINED
SYSTEMS

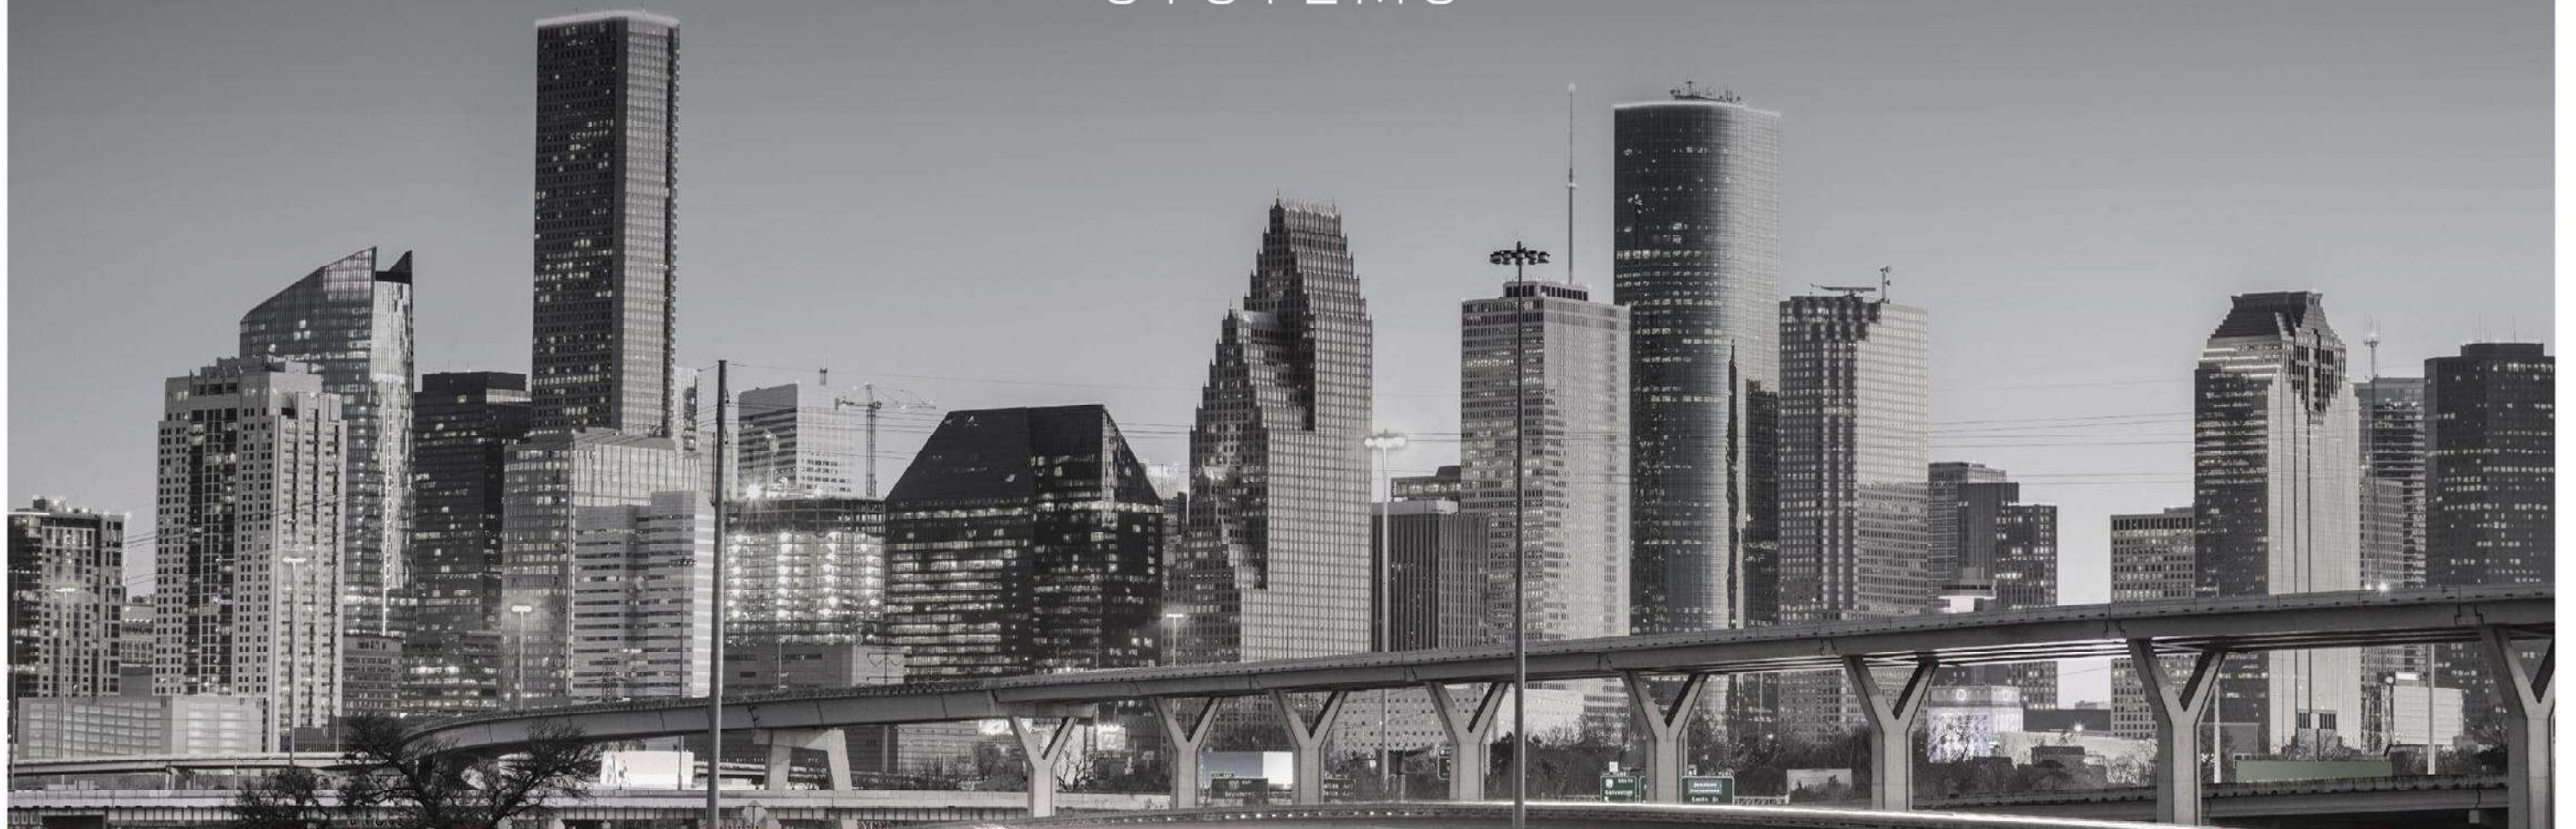

FUNCTIONAL | SOPHISTICATED | EFFORTLESS

 Projector	(1)Cat6AS, (1)Cat6 , (1)RG6
 Display	(1)Cat6AS, (1)Cat6 , (1)RG6
 Standard	(1) 16/4 HR In-Ceiling Speaker
 Small App	
 Floor Sub	(1) RG6 white – Floor standing sub
 In-wall Sub	
 In-Wall	(1) 16/4 HR – In-Wall Speaker
 Surface Mount	(1) 16/4 HR – Surface Mount Speaker
 Landscape	(1) 16/4 HR – Landscape Speaker
 Bookshelf	(1) 16/4 HR – Bookshelf Speaker
 Stub Out	(1) 16/4 HR, (1) Cat6 – Stub out
 Touchscreen	(1) Cat6 Black (No Box) – On-wall Touchscreen
 Data	(1) Cat6 – Data
 Wireless Access Point	(1) Cat6 – Wireless Access Point
 RF Gateway	(1) Cat6 – RF gateway
 Garage Control	(1) Cat6 – Garage Control
 Pool Control	(1) Cat6 – Pool Control
 Local Source	(2) Cat6 - Local Source
 Demarcation	(2) Cat6, (2) RG6, (1) 16/4, (1) Ground Wire
 Temperature Sensor	(1) Cat5 – Temp Sensor
 Camera	(1) Cat6 - Camera
 Door Station	(2) Cat6 (1) 16/4 – Door Phone Box
 Lighting Keypad	(1) Cresnet - Lighting LV Keypad
 Motorized Shade	(1) Cresnet HP – Motorized Shades
 Flex Conduit	1.5" Flexible Conduit
 Structured Cabling Enclosure	Structured Cabling Enclosure
 Equipment Rack	Equipment Rack
Can to Rack Jumpers Security to Rack Jumpers	(4) Cat6 (1) 1.5" Flex (4) RG6 white (2) Cat6

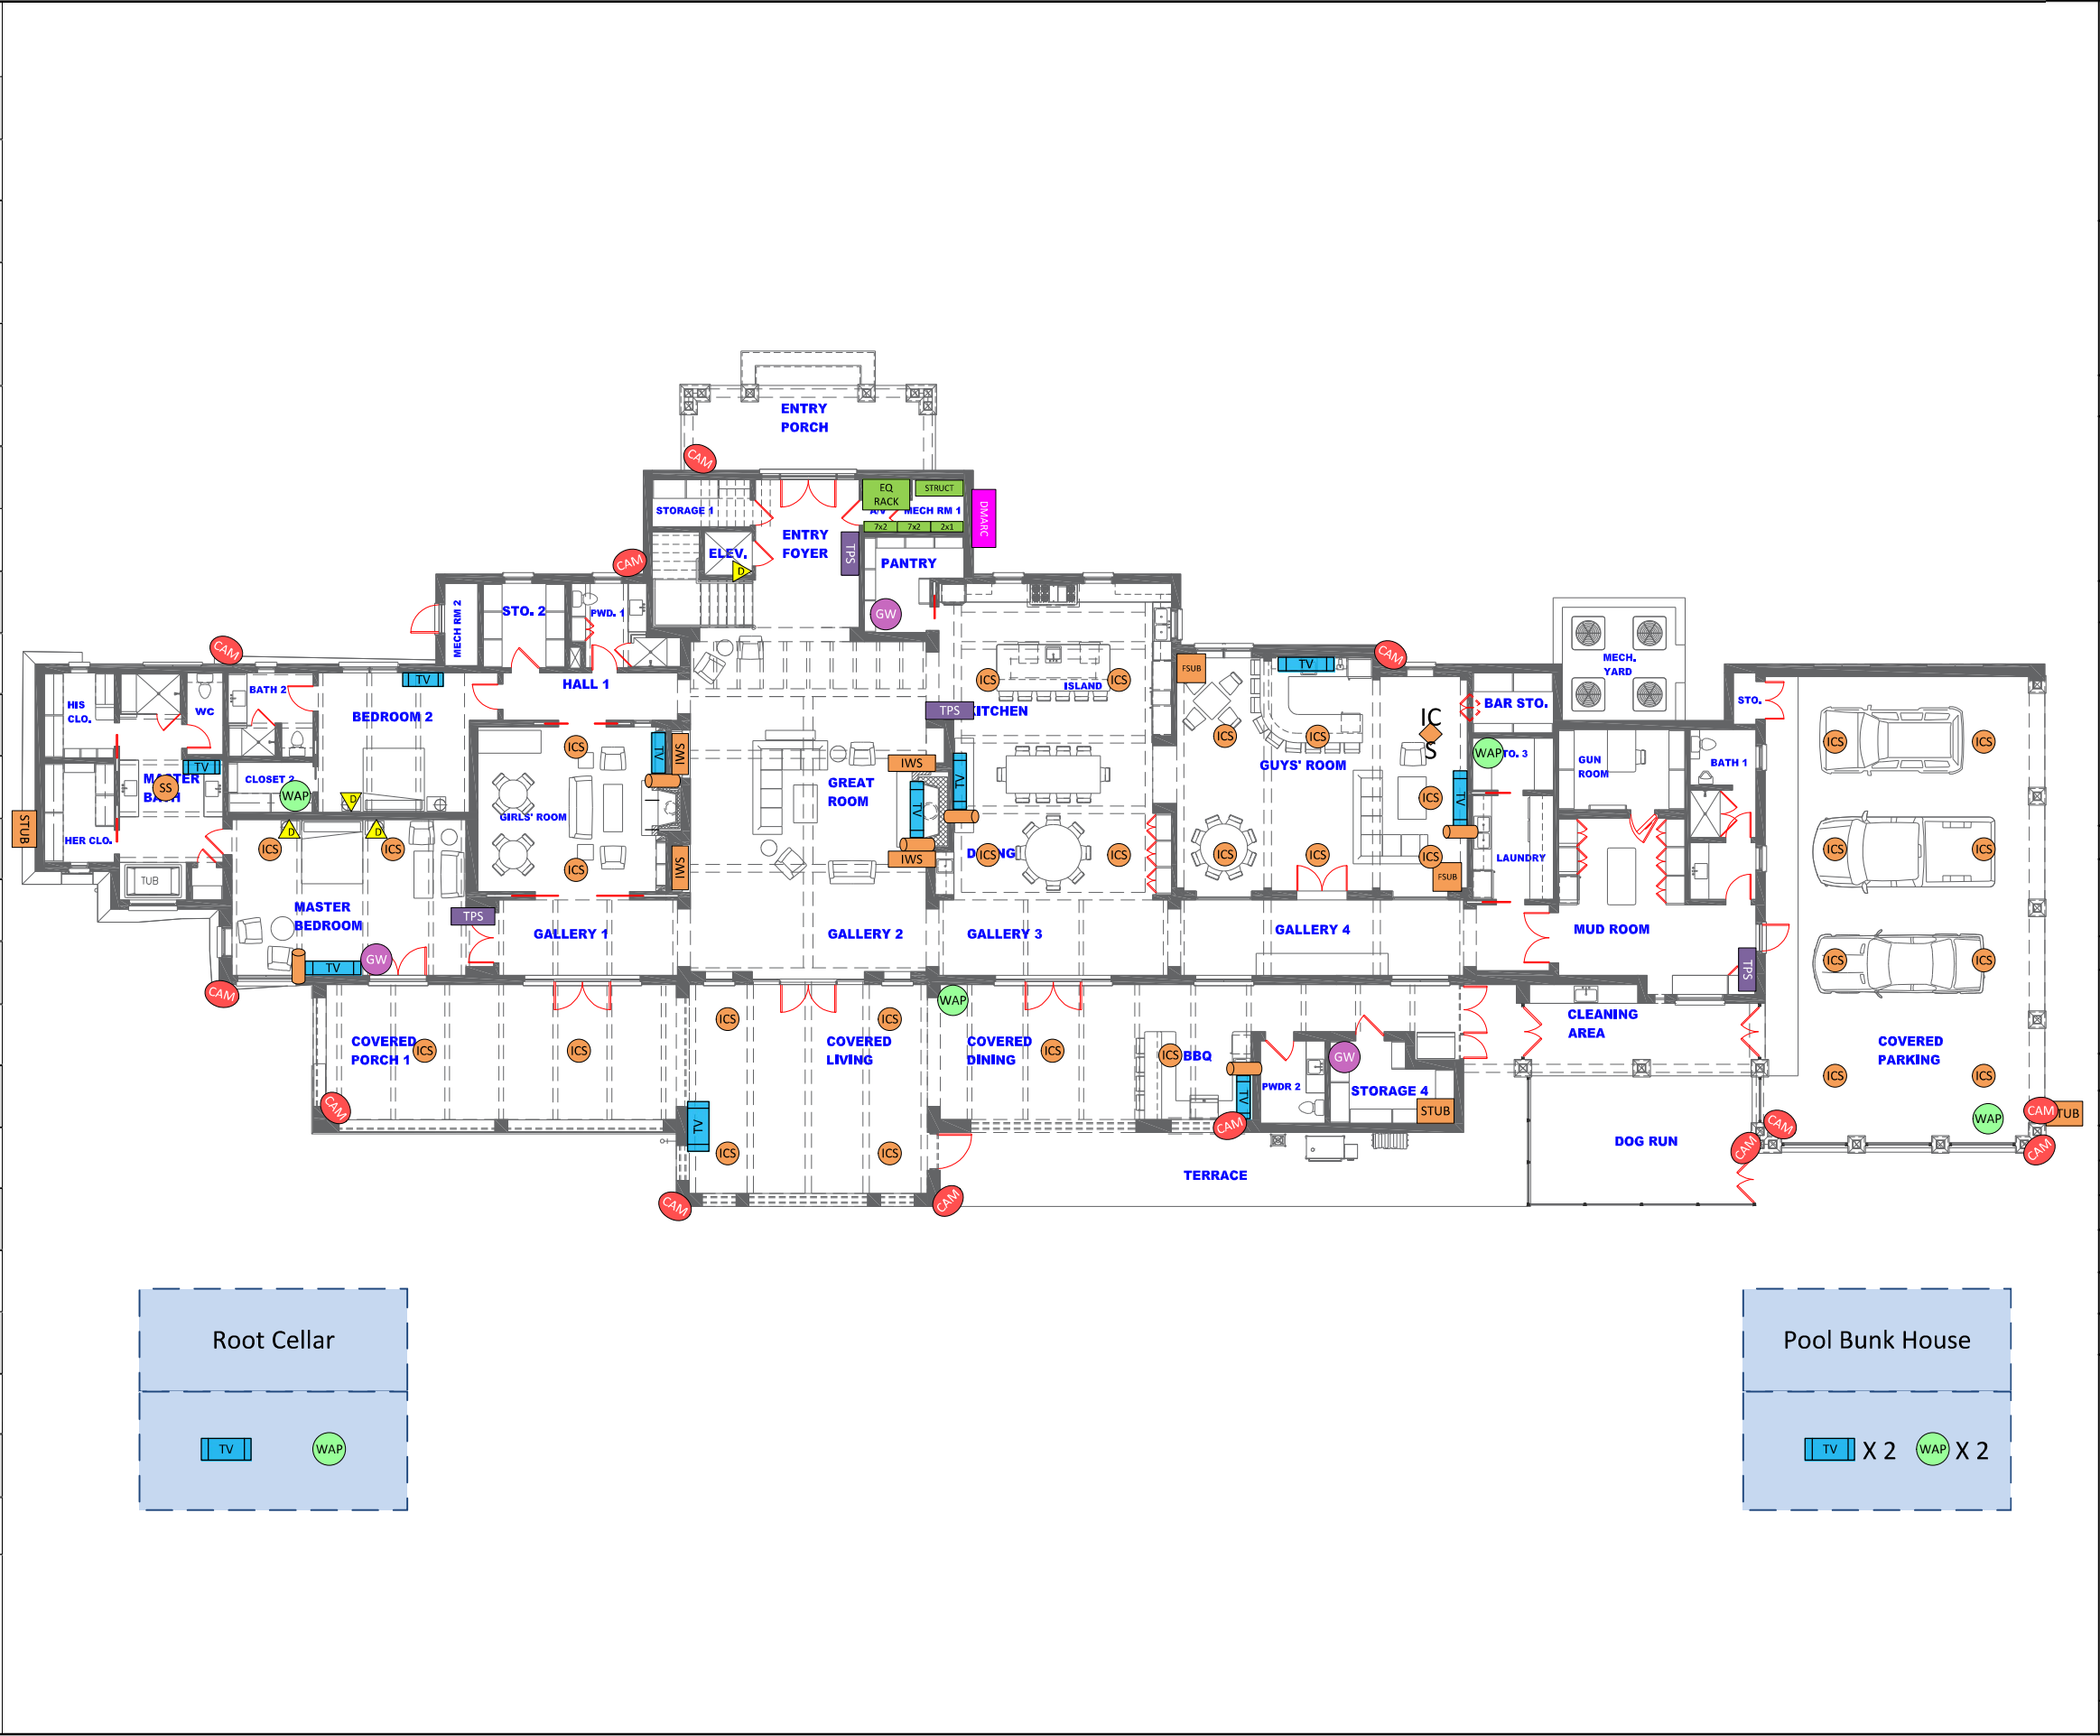



18801 Intercontinental Crossing Dr
Houston TX 77073

Client:

Name

Address:

Address

Architect:

Architect

Builder/Contractor:

Builder

Date: 2019/xx/xx

Rev 1:

Rev 2:

Rev 3:

Rev 4:

 
Drawn By:

Designer

DWG #: 0

1st Floor Cabling Locations

Submitted To Client: 2019/xx/xx



Name

Address

Architect

Builder

Rev 1:

Rev 2:

Rev 3

Rev 4


Drawn By:


Designer

DWG #: 0

2nd Floor Cabling Locations

Submitted To Client: 2019/xx/xx

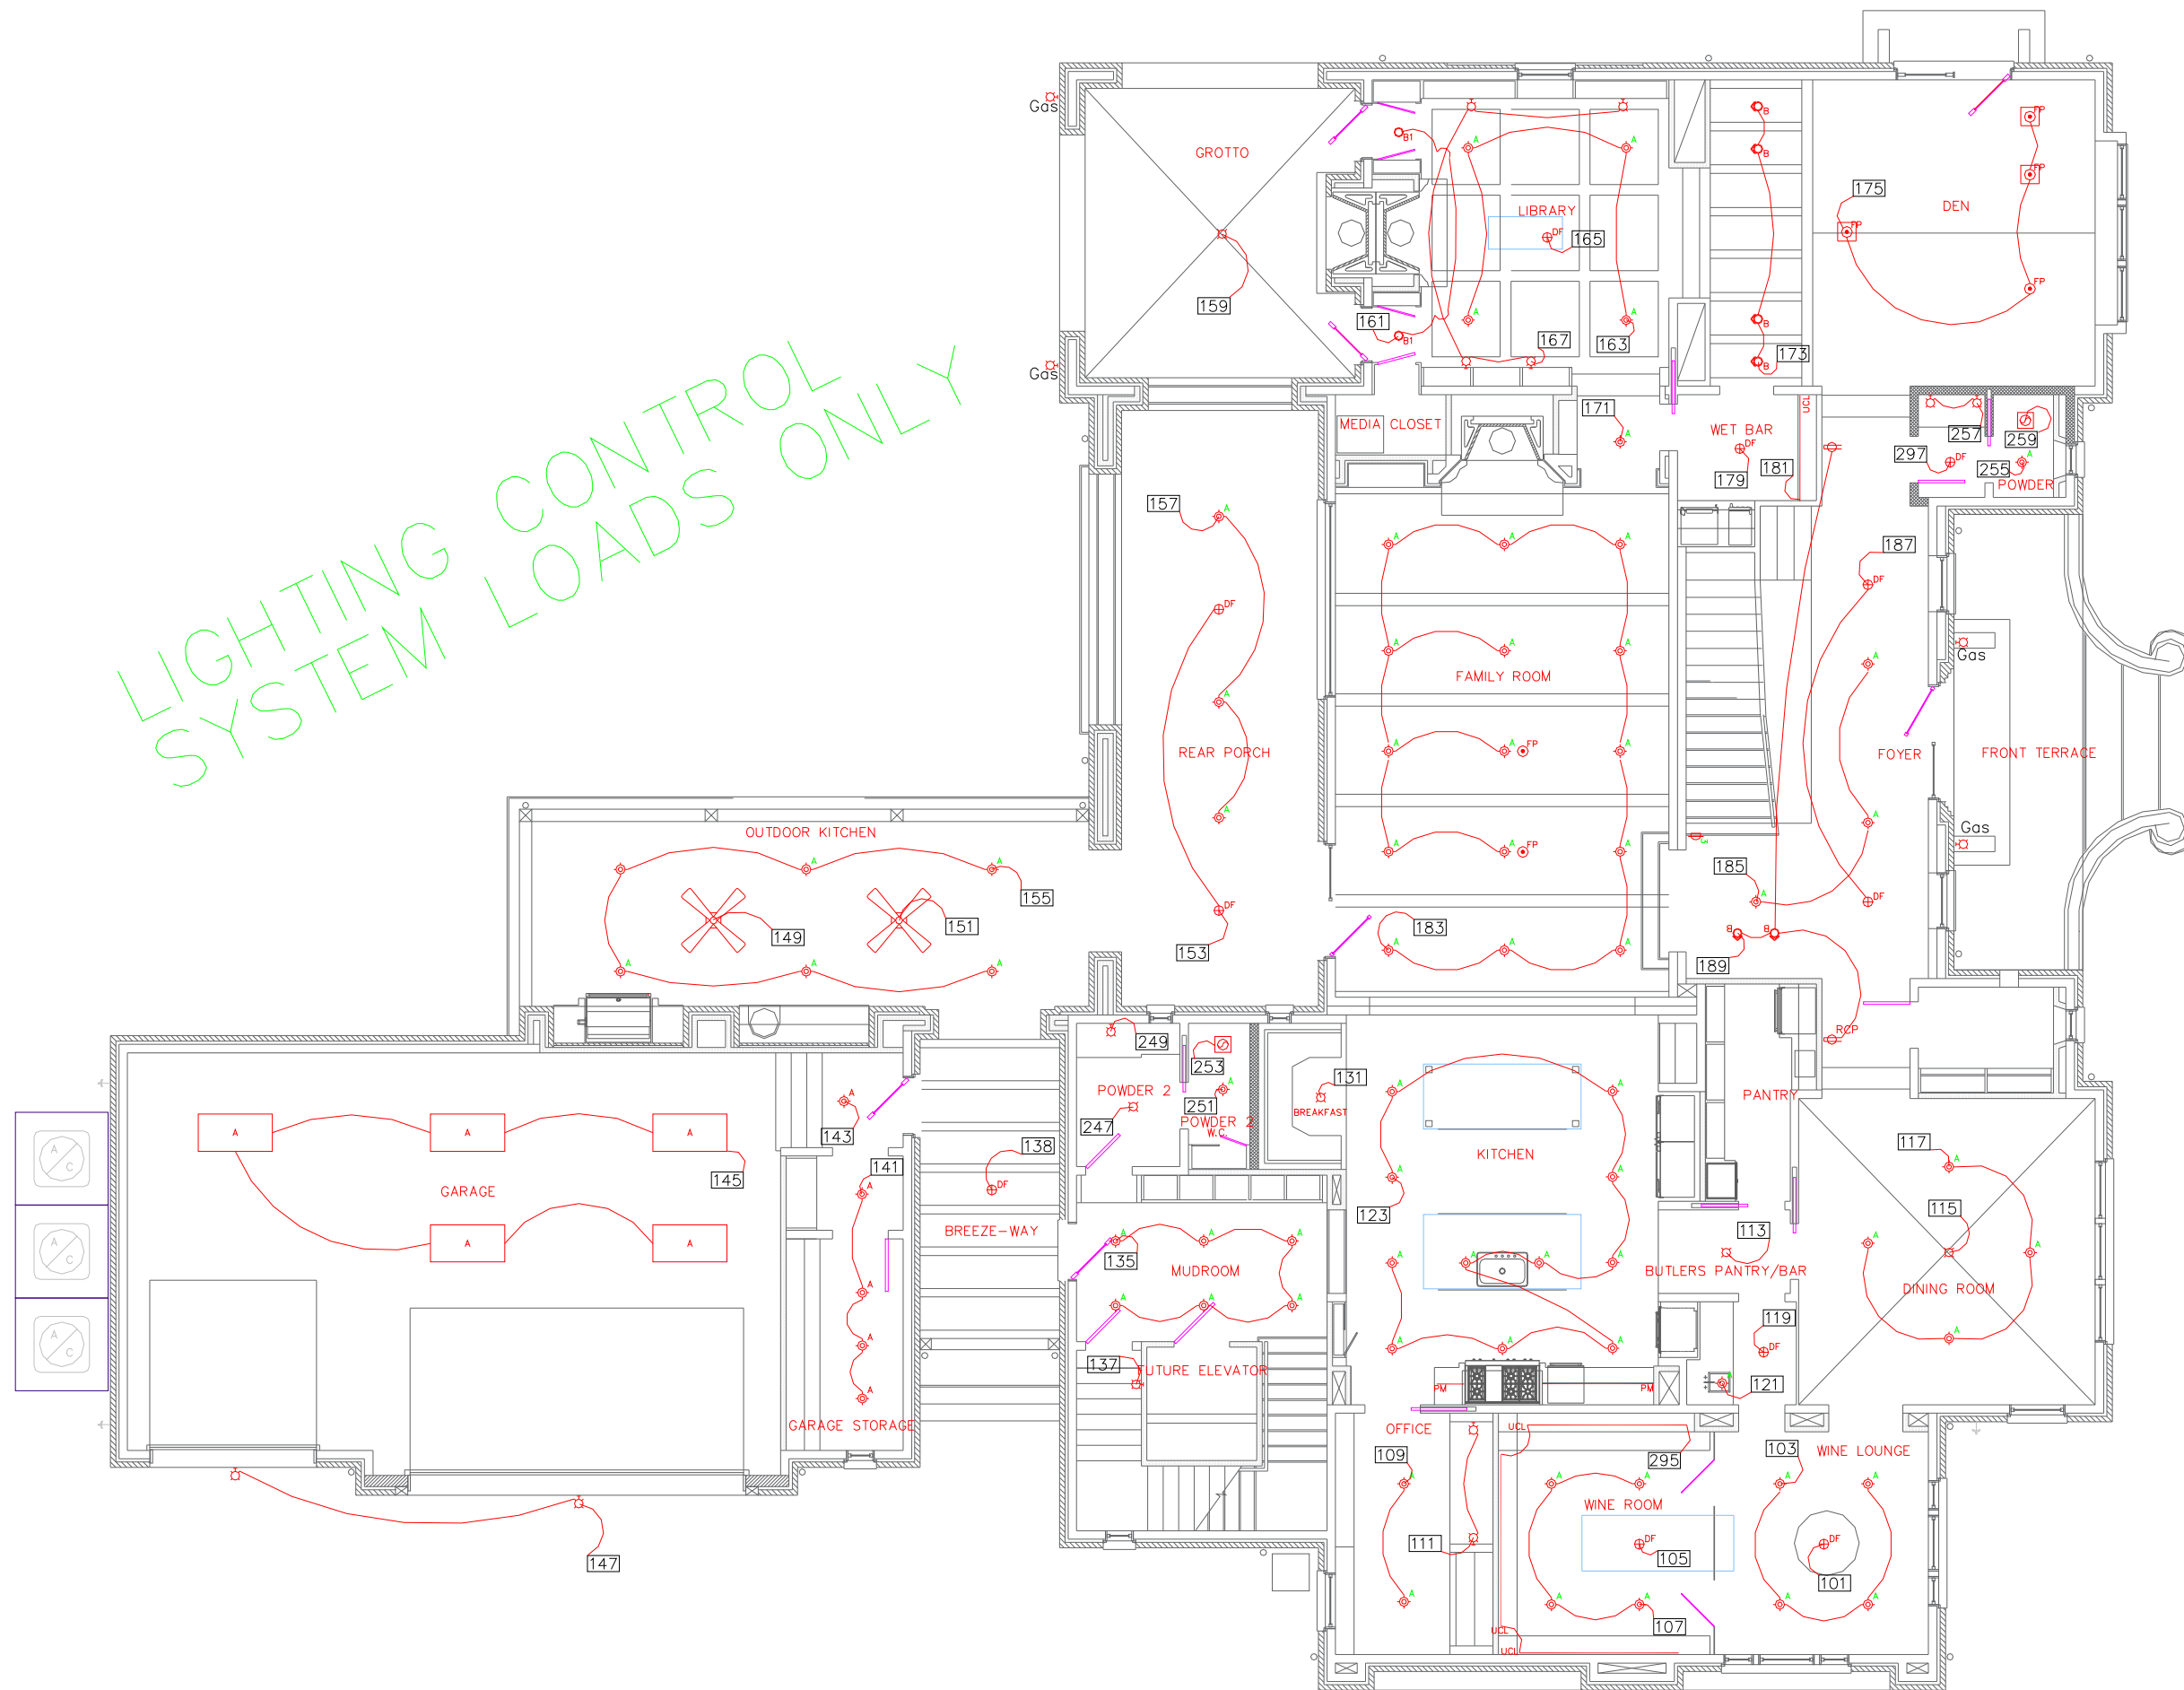

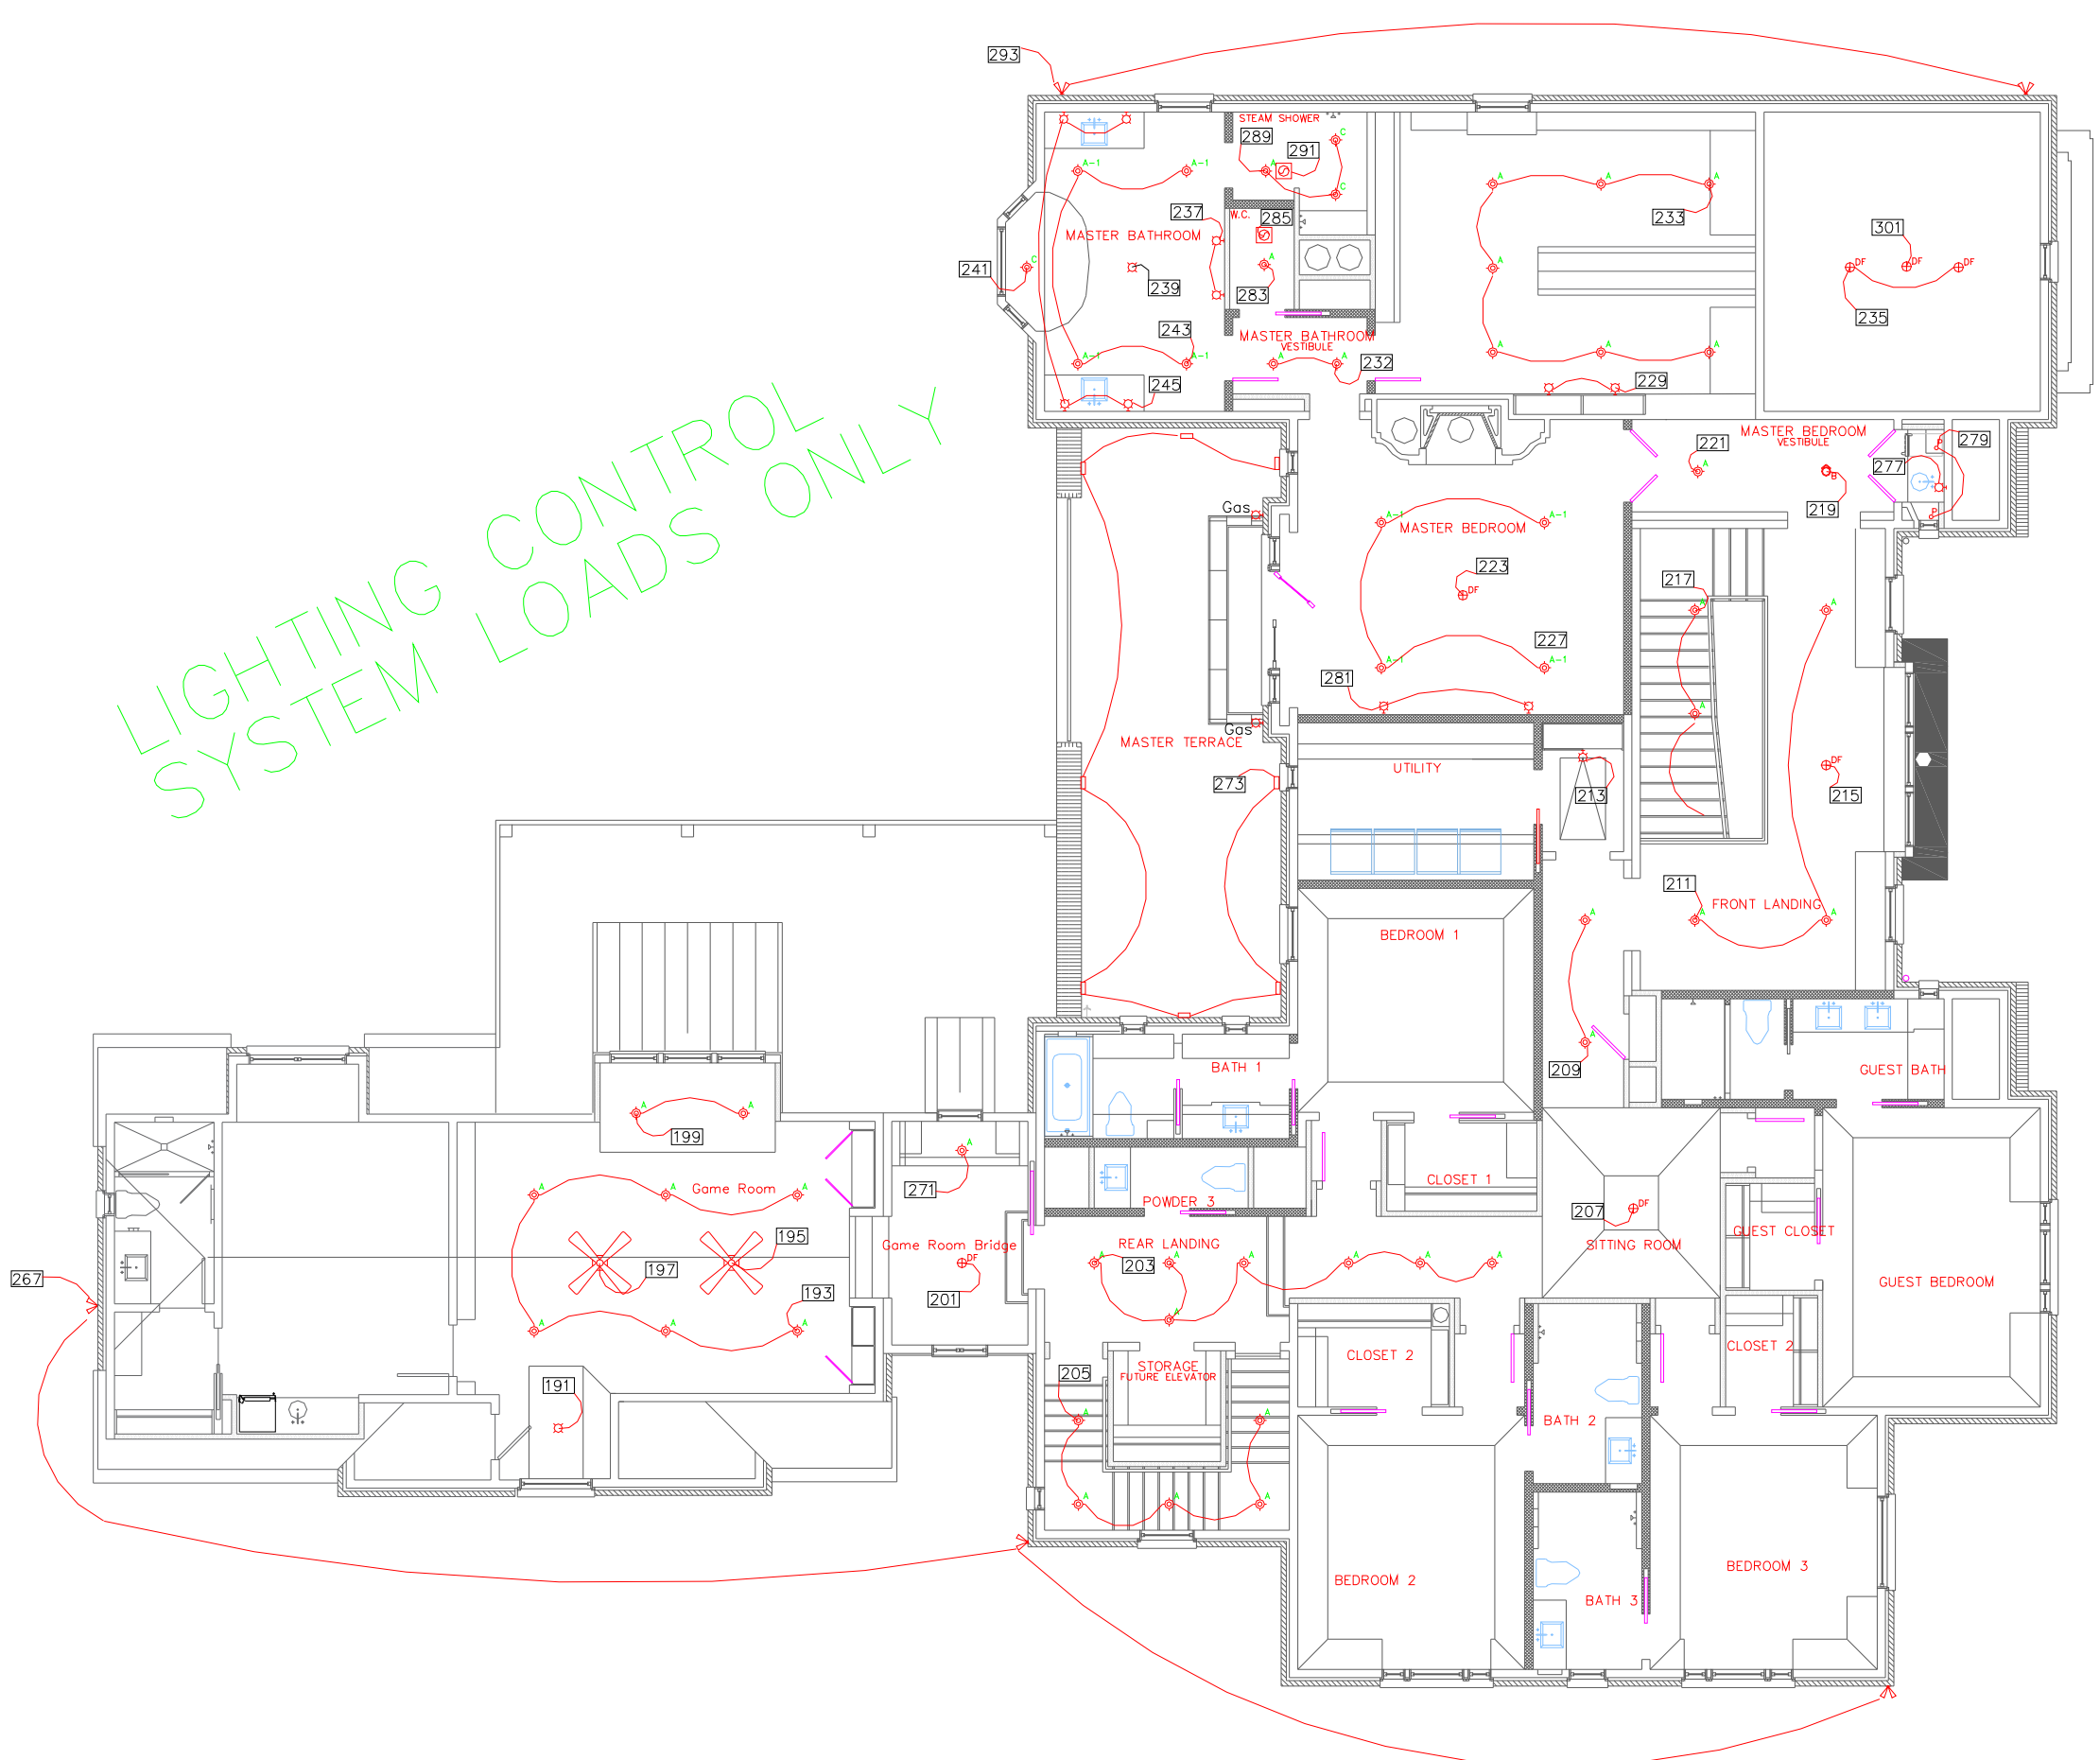

18801 Intercontinental Crossing Dr
Houston TX 77073

Client:

Name

Address:

Address

Architect:

Architect

Builder/Contractor:

Builder

Date: 2019/xx/xx

Rev 1:

Rev 2:

Rev 3

Rev 4


Drawn By:

Designer

DWG #: 0

2nd Floor Lighting

Submitted To Client: 2019/xx/xx

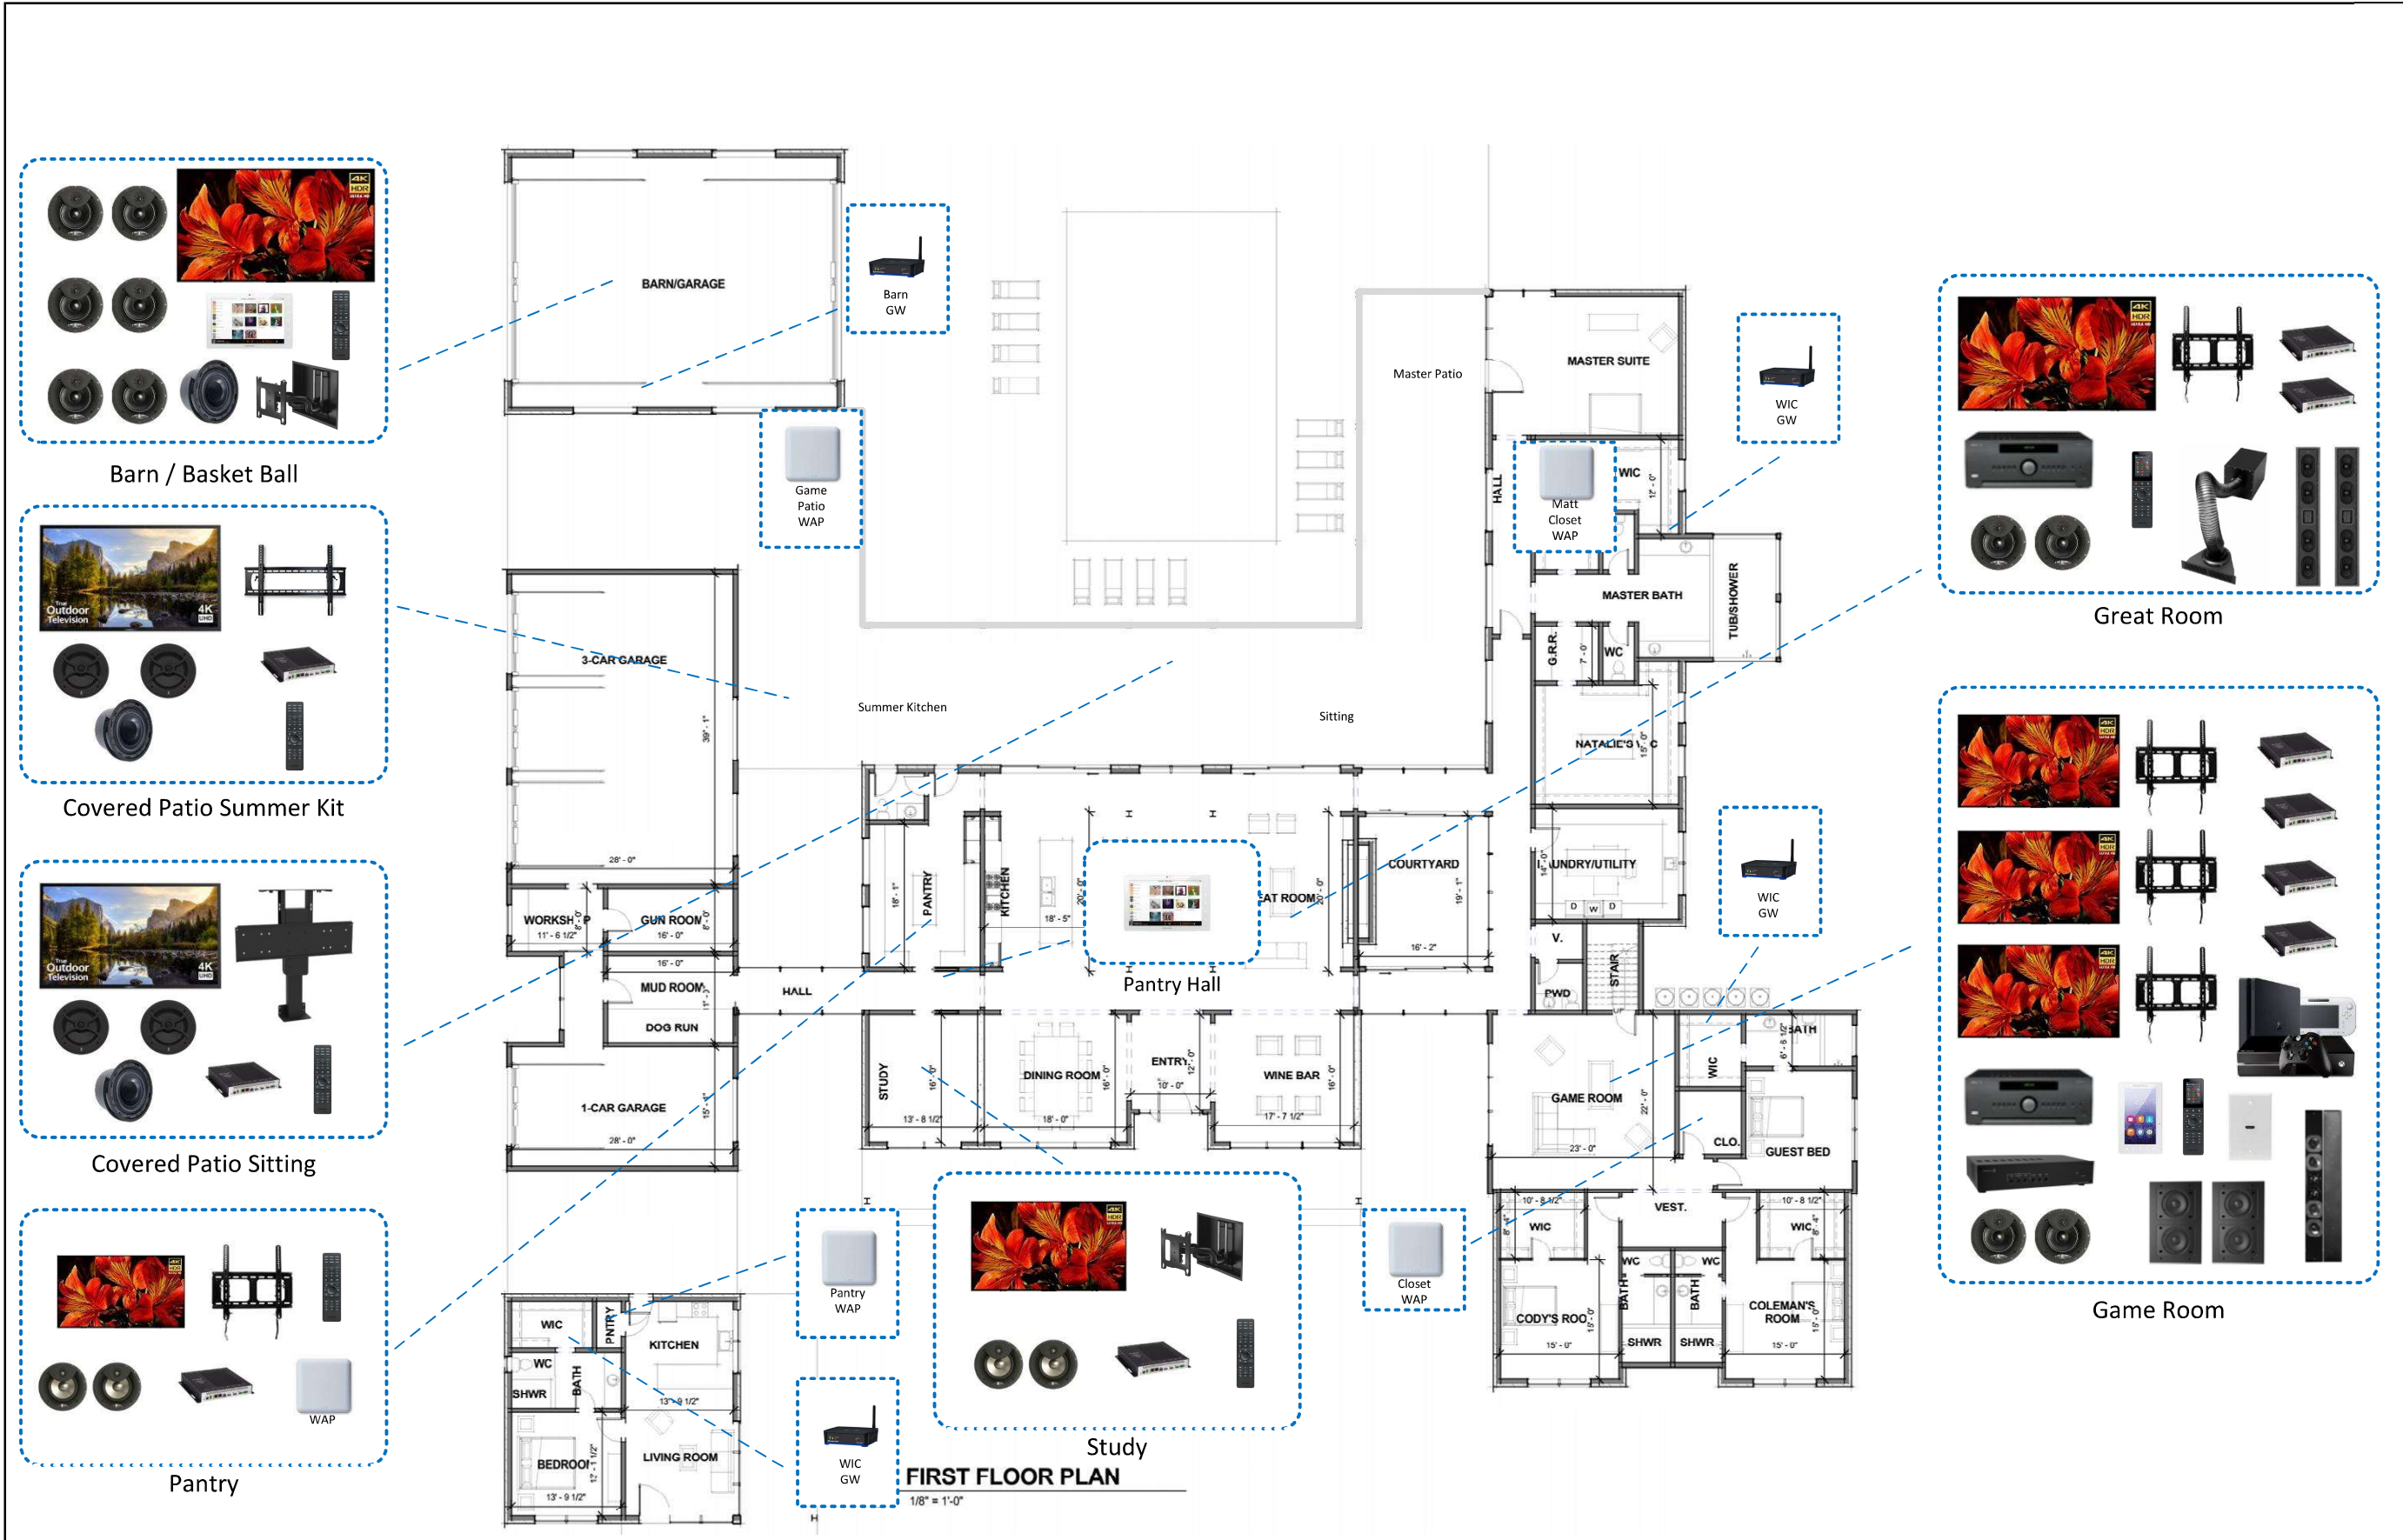

 REFINED SYSTEMS	
18801 Intercontinental Crossing Dr Houston TX 77073	
Client:	
Name	
Address:	
Address	
Architect:	
Architect	
Builder/Contractor:	
Builder	
Date:	2019/xx/xx
Rev 1:	
Rev 2:	
Rev 3:	
Rev 4:	
Drawn By:	
Designer	
DWG #:	0
1st Floor Functional	
Submitted To Client: 2019/xx/xx	



Master Bathroom



Kitchen



Wine



3 Car Garage



Courtyard



Master Patio



Natalie's Closet



Dining Room



Single Stereo Speaker




Single Stereo Speaker



Covered Porch



Game Patio

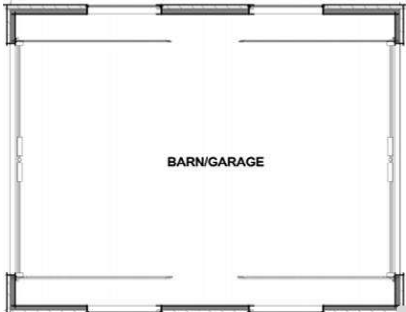

BARN/GARAGE




Master Bedroom



Casita Living Room




Casita Bedroom

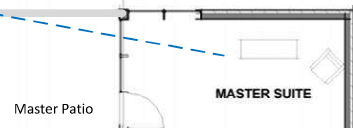

Master Suite



Master Bath

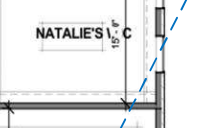

Natalie's C



MATT'S WIC



TUB/SHOWER



WC



G.R.R



Summer Kitchen



GREAT ROOM



WINE BAR




ENTRY



COURTYARD



GAME ROOM

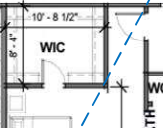

CODY'S ROO



COLEMAN'S ROOM



GUEST BED



VEST.



WIC



BATH



SHWR



WC



WIC



BATH



 
SHWR



WC




Casita Kitchen




Casita Living Room



 Casita Bedroom



Casita Bath

 

Casita WIC



Casita Pntry



Casita Shwr



Casita Mud Room



Casita Dog Run



Casita Gun Room




Casita Worksh



Casita 1-CAR GARAGE



 Casita 3-CAR GARAGE



Casita Master Patio





Cameras



REFINED
SYSTEMS

18801 Intercontinental Crossing Dr
Houston TX 77073

Client:

Name

Address:

Address

Architect:

Architect

Builder/Contractor:

Builder

Date: 2019/xx/xx

Rev 1:

Rev 2:

Rev 3:

Rev 4:


Drawn By:

Designer

DWG #: 0

2nd FloorFunctional

Submitted To Client: 2019/xx/xx

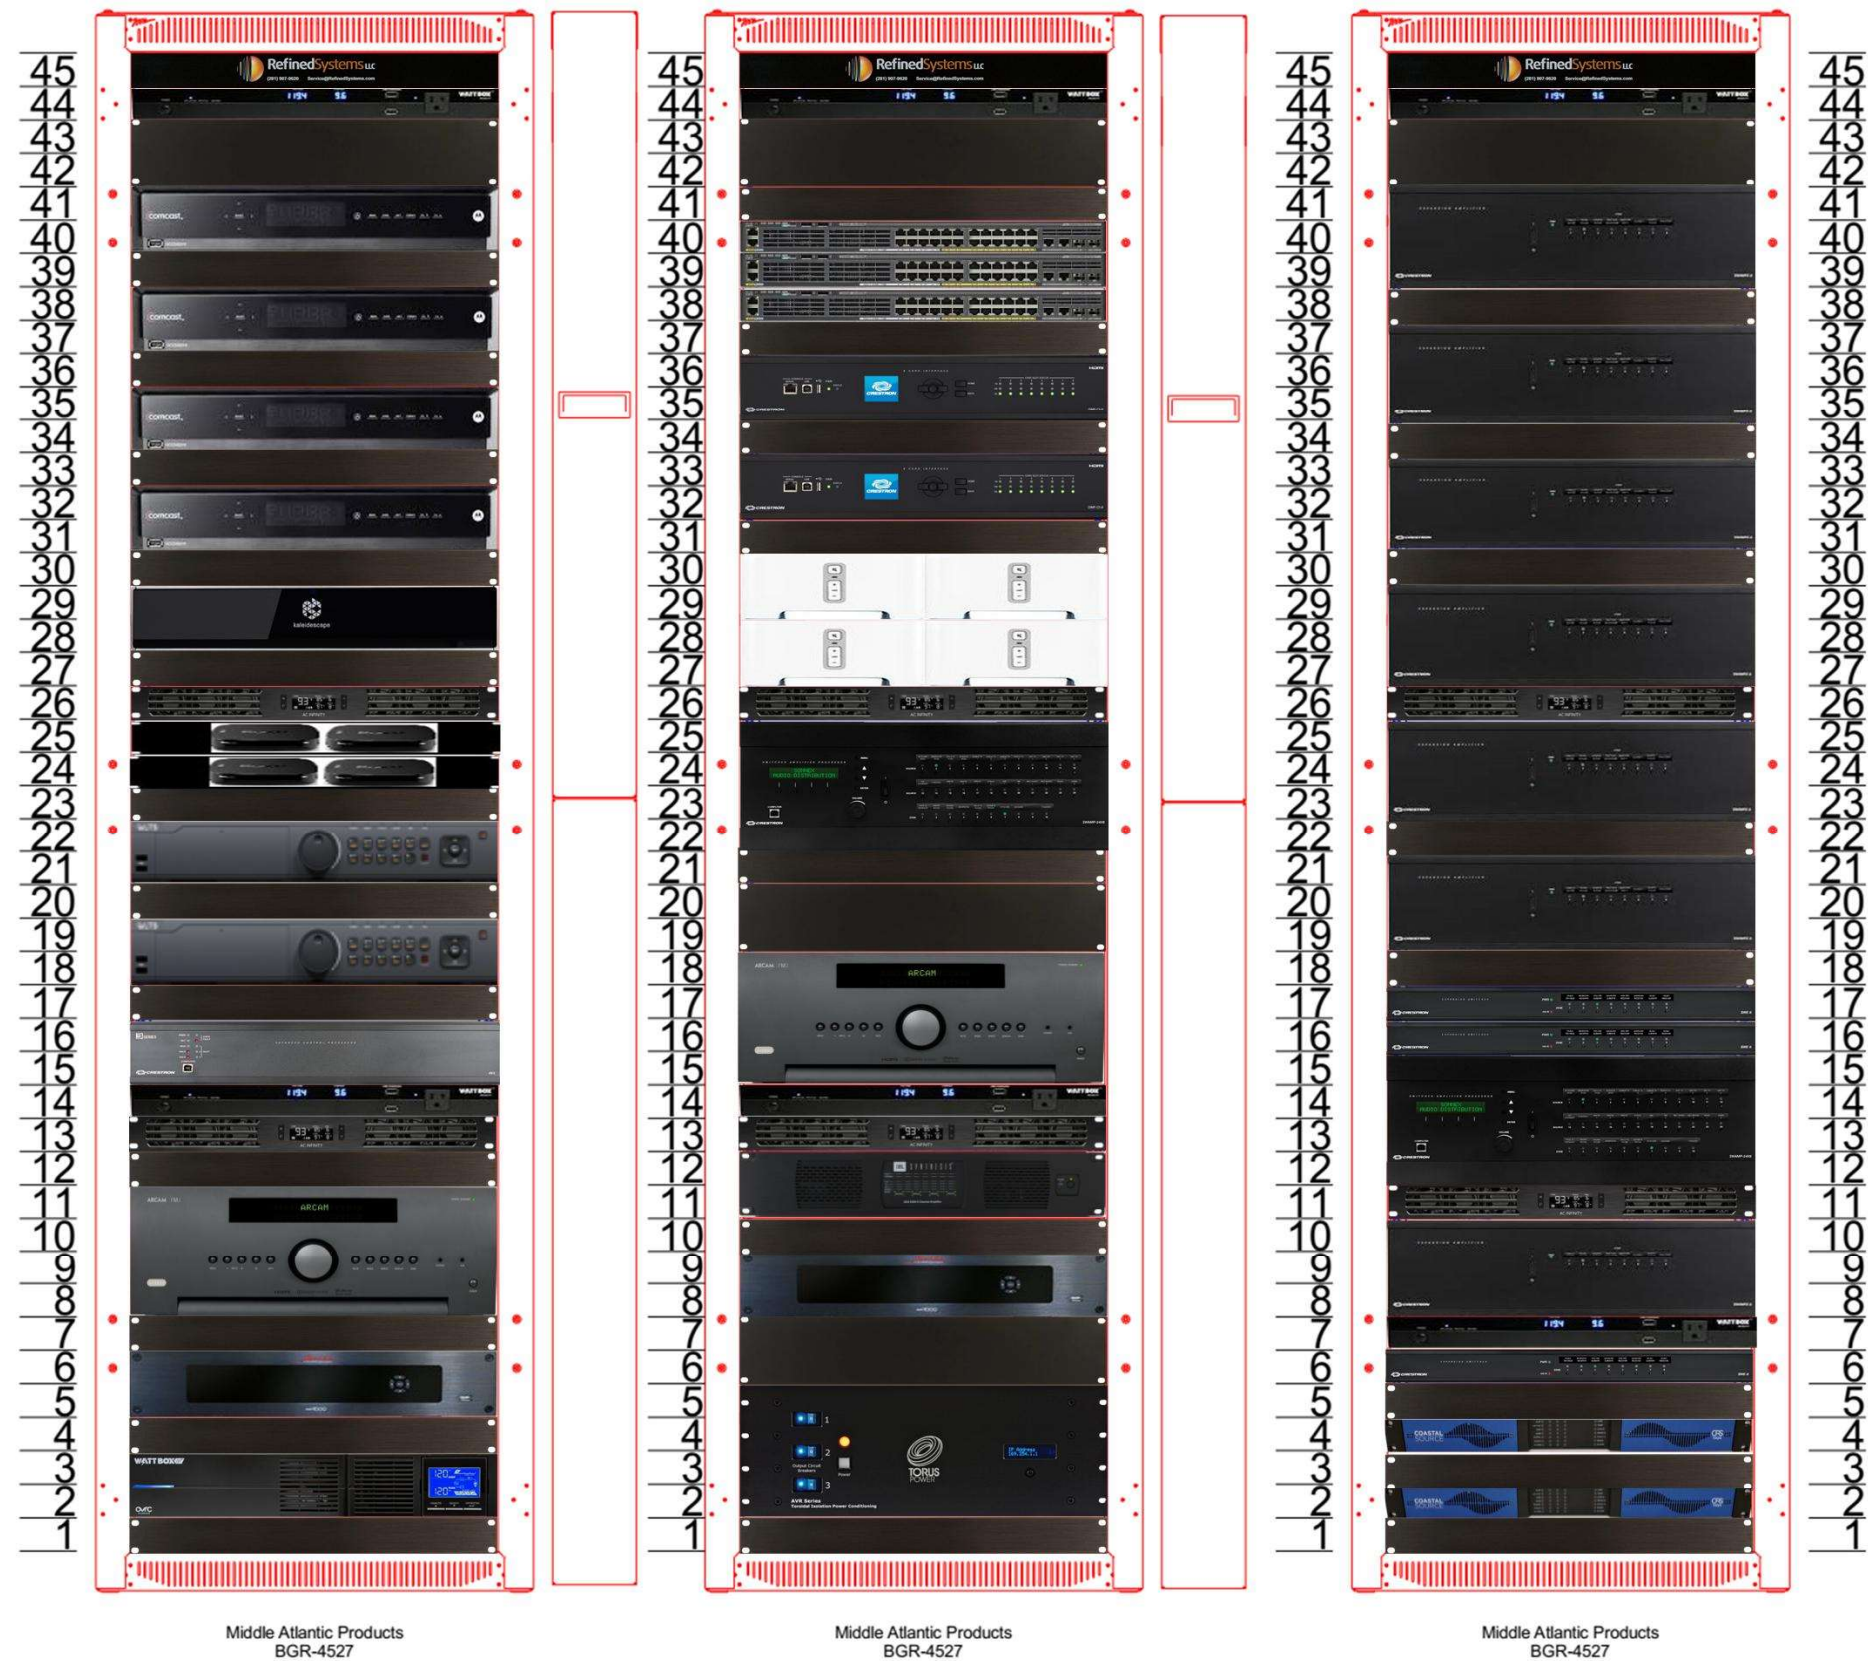


REFINED
SYSTEMS

18801 Intercontinental Crossing Dr
Houston TX 77073

Client:

Name

Address:

Address

Architect:

Architect

Builder/Contractor:

Builder

Date: 2019/xx/xx

Rev 1:

Rev 2:

Rev 3

Rev 4

Drawn By:

Designer

DWG #: 0

Rack Layout

Submitted To Client: 2019/xx/xx



18801 Intercontinental Crossing Dr
Houston TX 77073

Client:

Name

Address:

Address

Architect:

Architect

Builder/Contractor:

Builder

Date: 2019/xx/xx

Rev 1:

Rev 2:

Rev 3

Rev 4


Drawn By:

Designer

DWG #: 0

Line Diagram

Submitted To Client: 2019/xx/xx

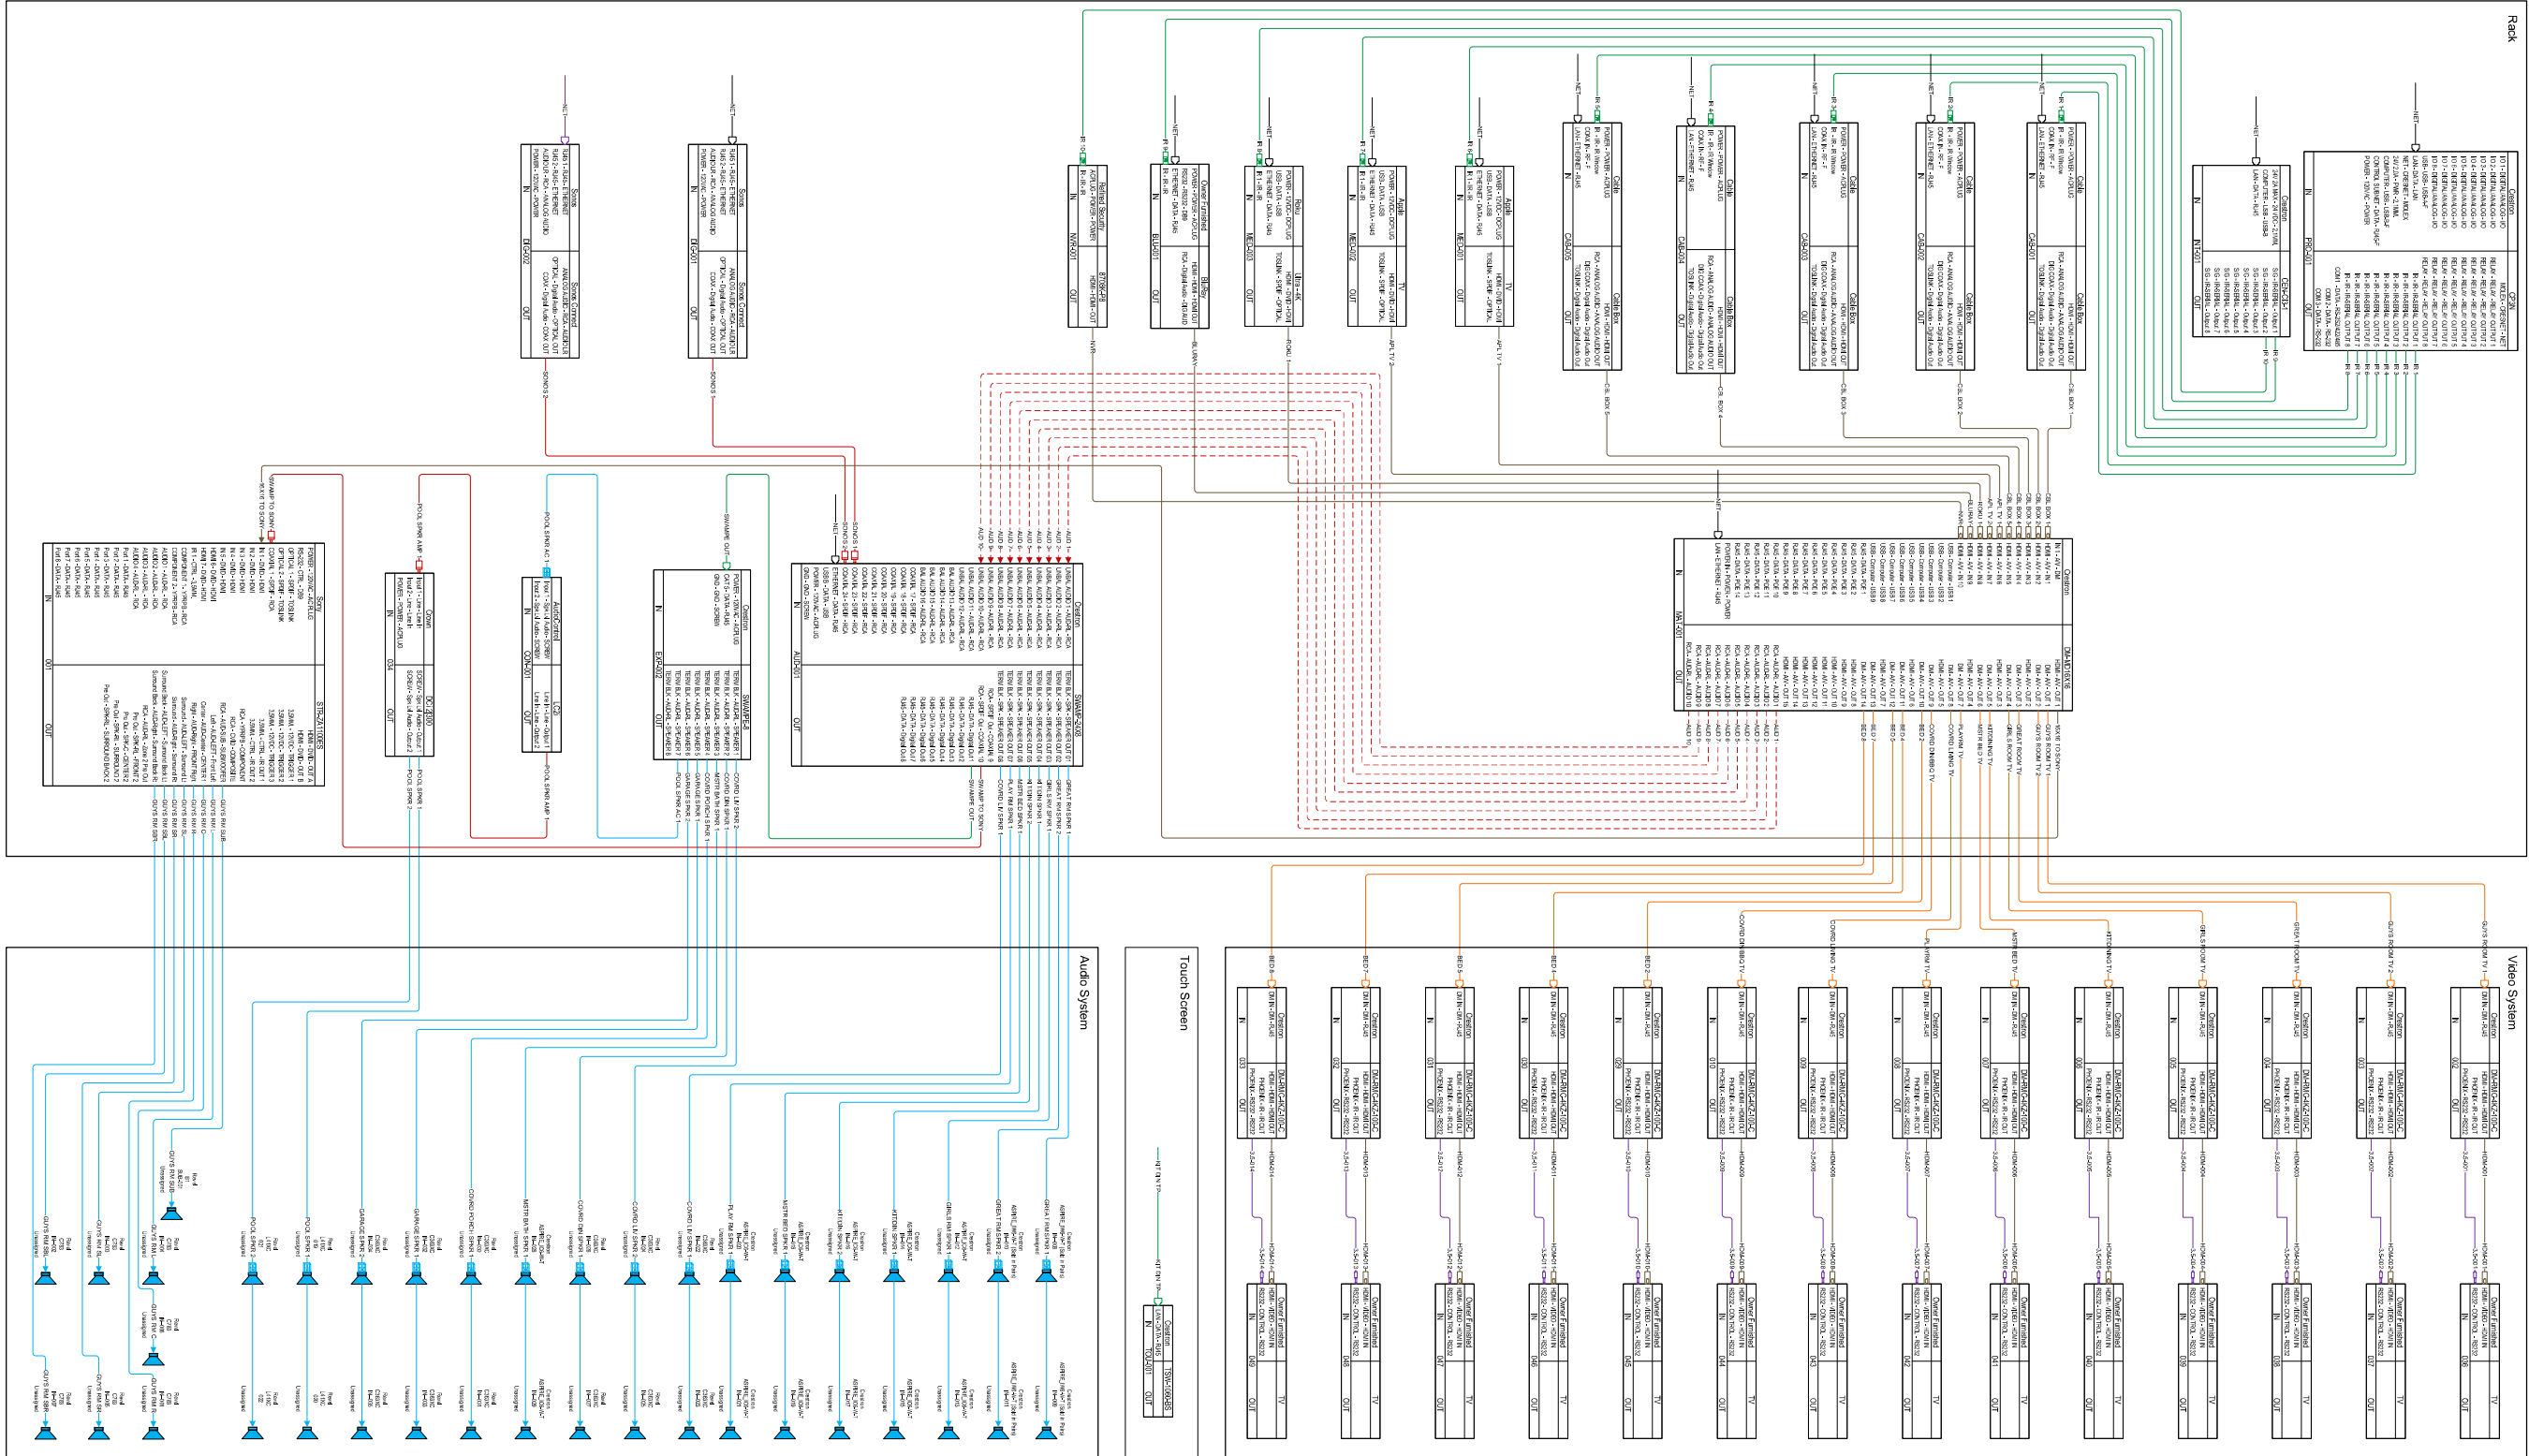



REFINED
SYSTEMS

18801 INTERCONTINENTAL CROSSING DRIVE, HOUSTON, TX 77073 281.907.9620

REFINEDSYSTEMS.COM